



NO.	BY	CHKD	APRV	REVISION	DATE

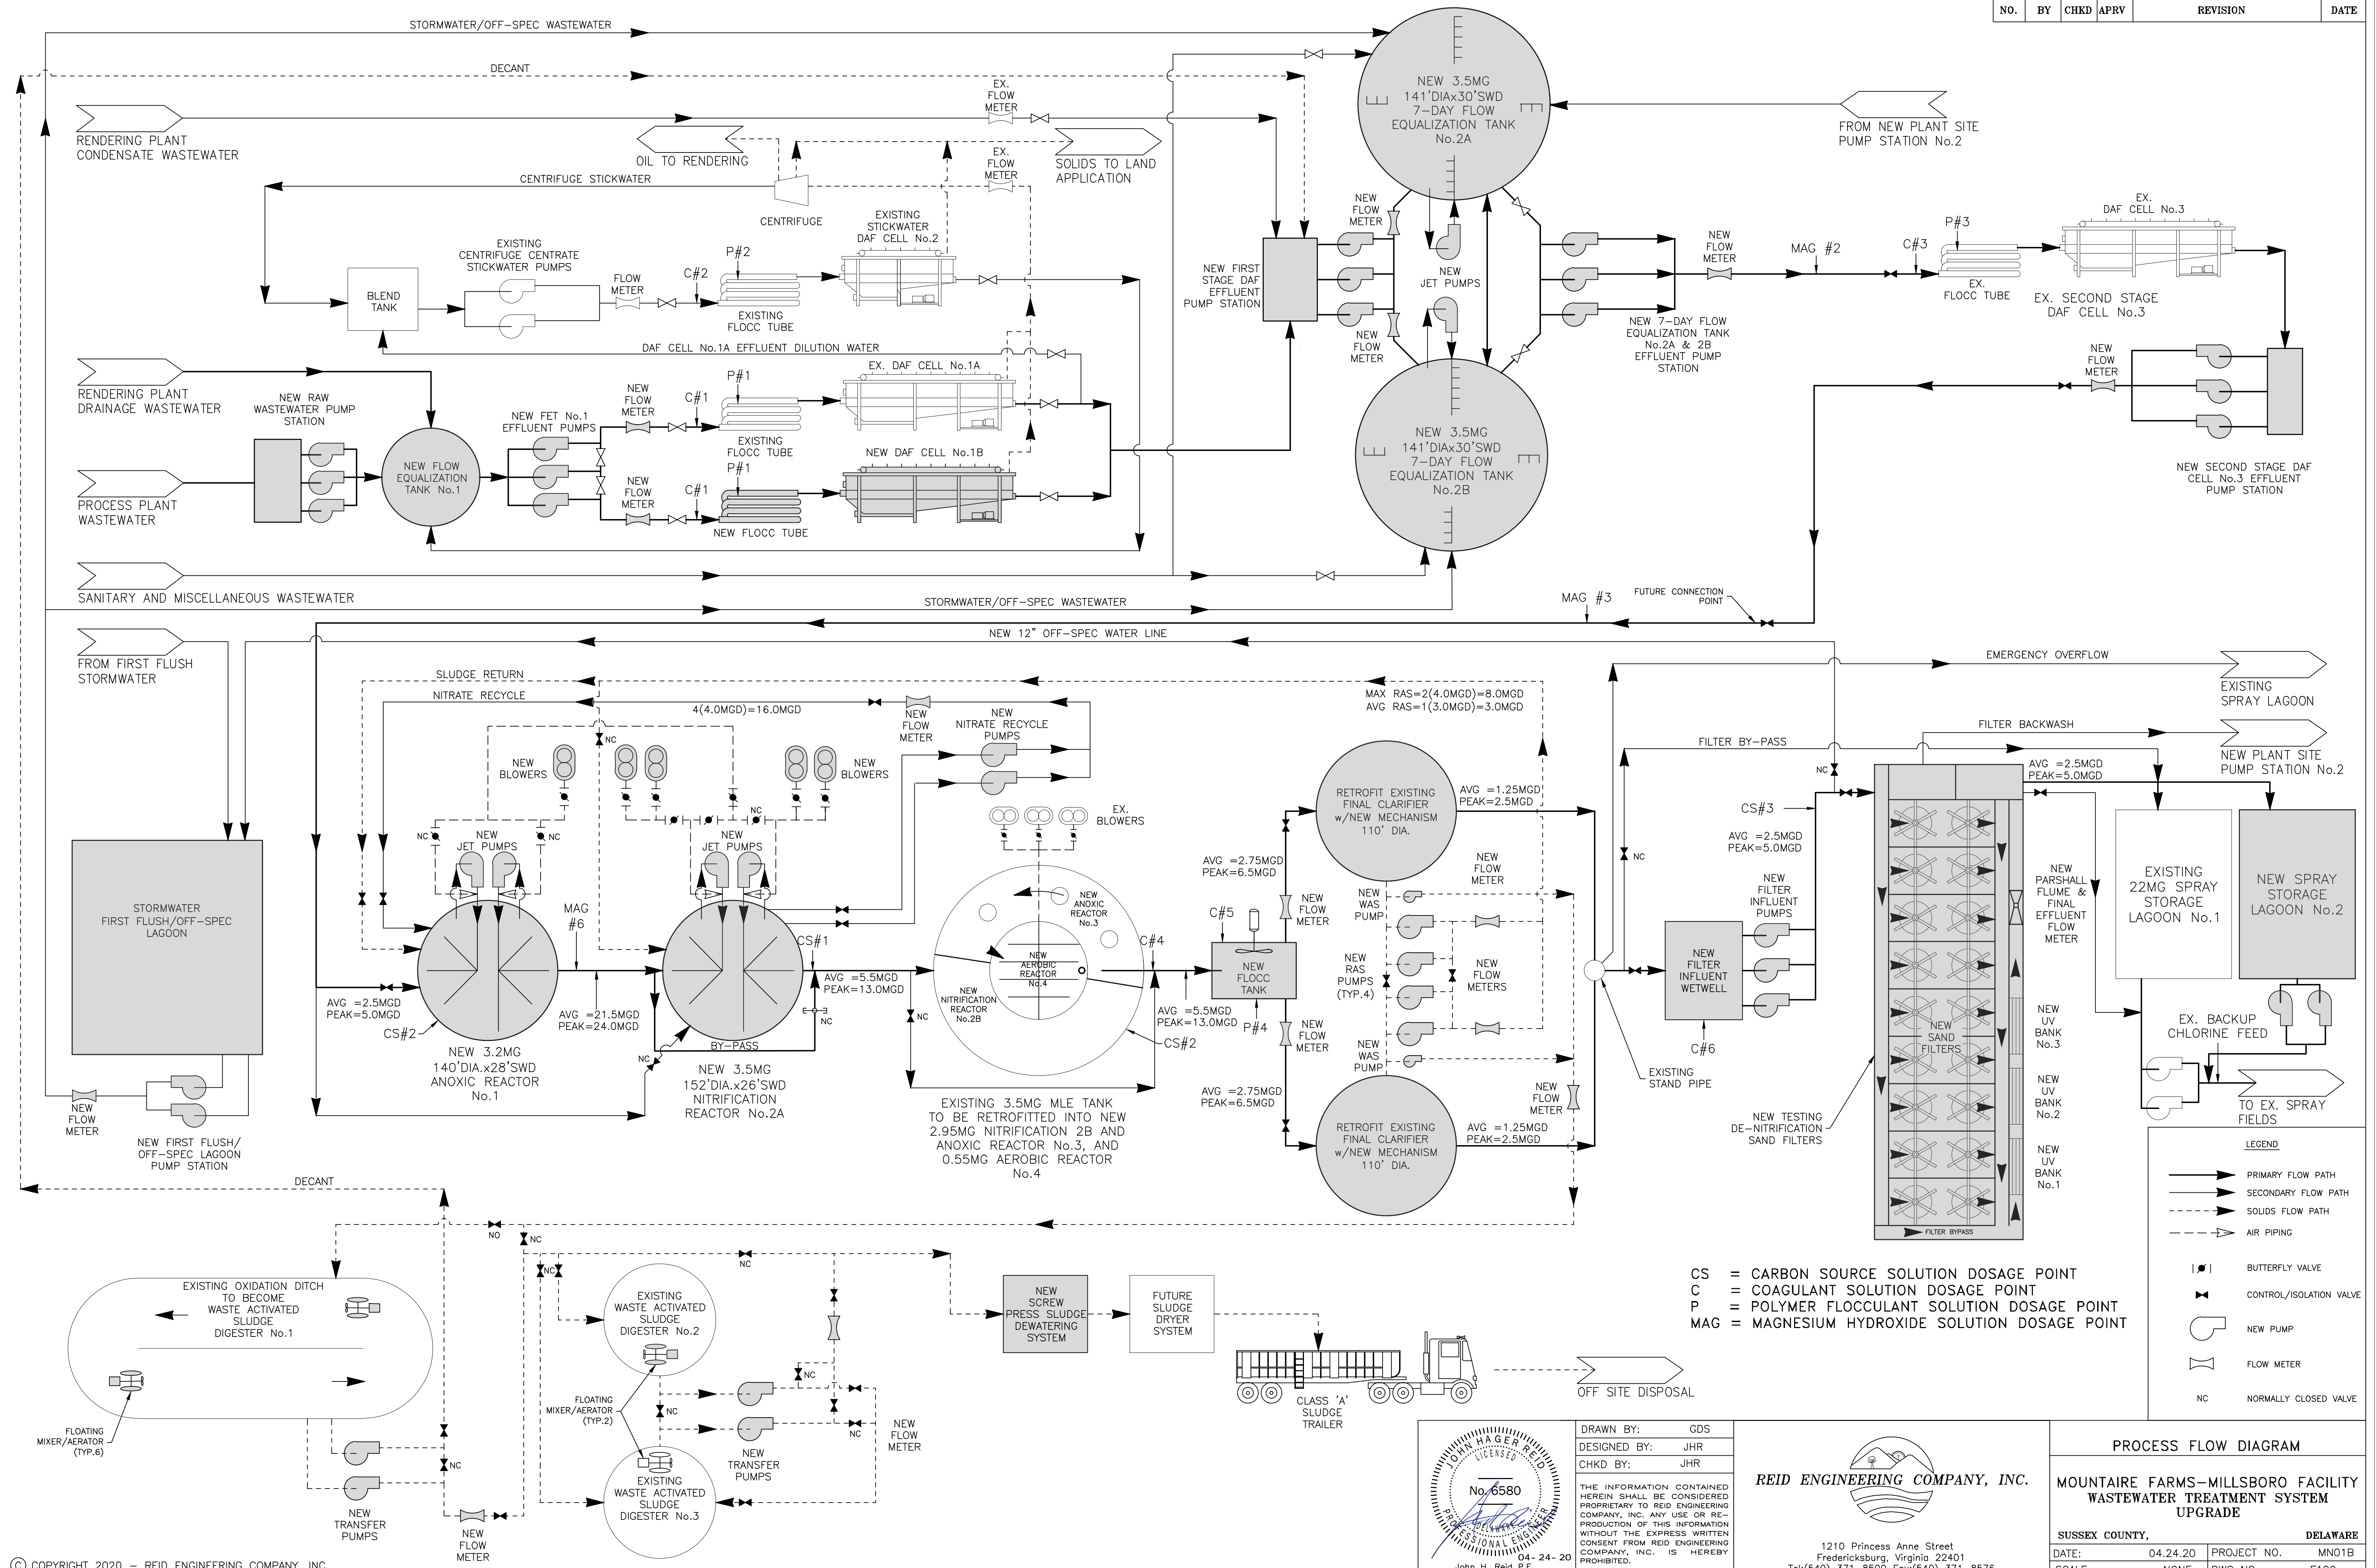

© COPYRIGHT 2020 - REID ENGINEERING COMPANY, INC.

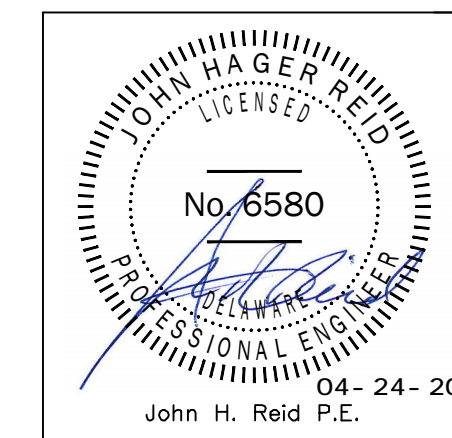

DRAWN BY: GDS
 DESIGNED BY: JHR
 CHKD BY: JHR
 THE INFORMATION CONTAINED HEREIN SHALL BE CONSIDERED PROPRIETARY TO REID ENGINEERING COMPANY, INC. ANY USE OR REPRODUCTION OF THIS INFORMATION WITHOUT THE EXPRESS WRITTEN CONSENT FROM REID ENGINEERING COMPANY, INC. IS HEREBY PROHIBITED.

REID ENGINEERING COMPANY, INC.
 1210 Princess Anne Street
 Fredericksburg, Virginia 22401
 Tel:(540) 371-8500 Fax:(540) 371-8576

PROCESS FLOW DIAGRAM	
MOUNTAINE FARM-MILLSBORO FACILITY WASTEWATER TREATMENT SYSTEM UPGRADE	
SUSSEX COUNTY, DELAWARE	
DATE: 04.24.20	PROJECT NO. MN01B
SCALE: NONE	DWG NO: F100